



SITE PLAN

SCALE 1:1300

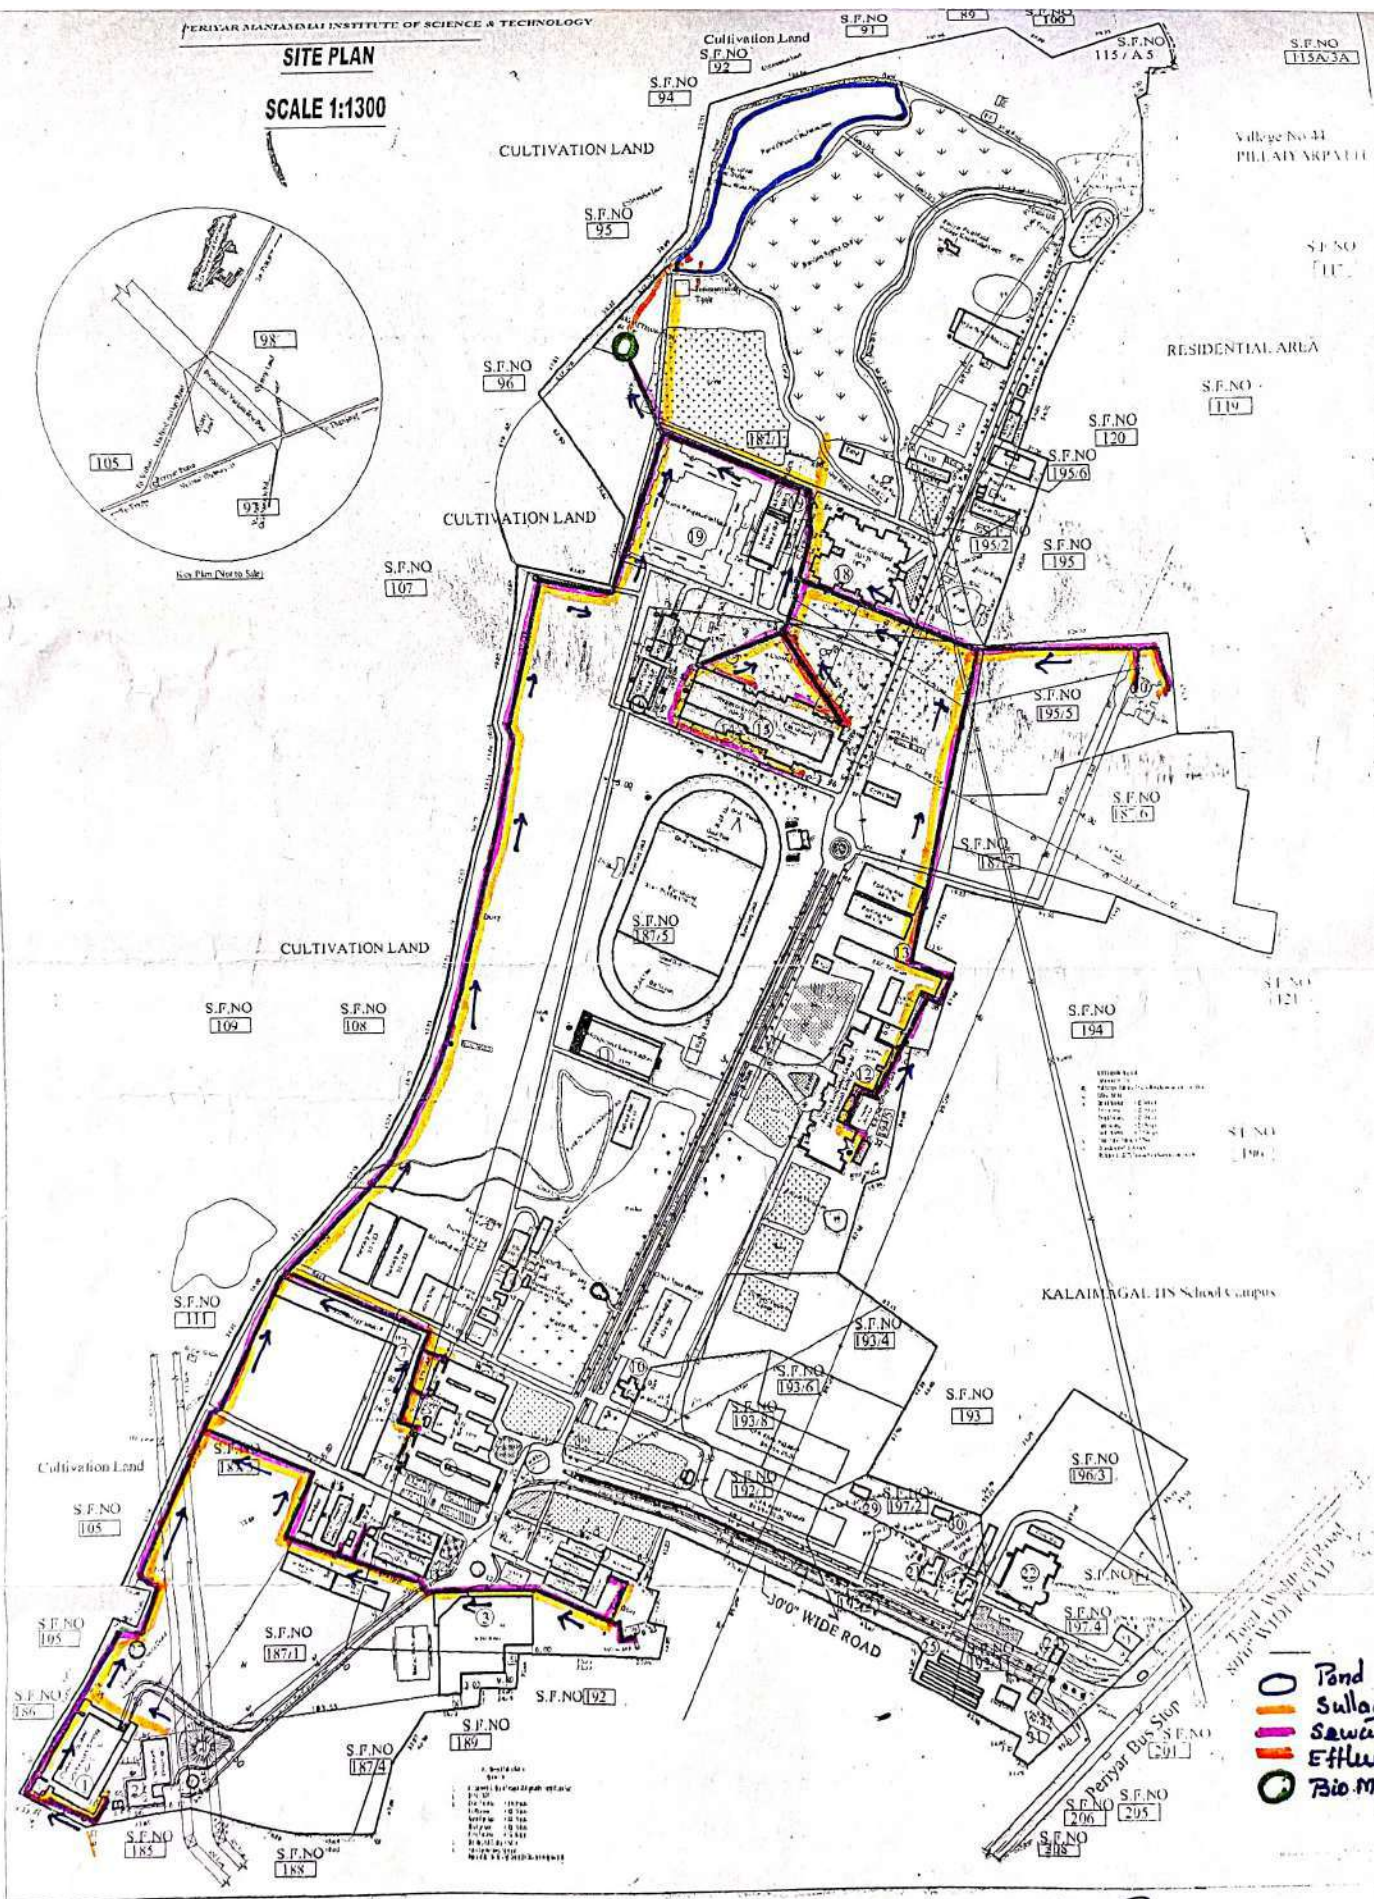

- Pond
- Sullage
- Sewage
- Bio-meth. Plant

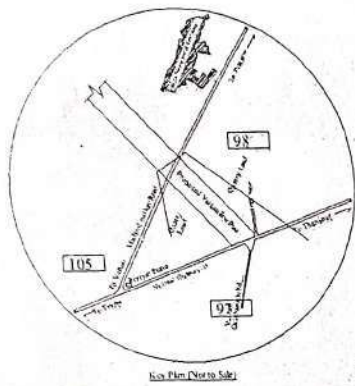

PERIYAR MANIAMMAI
 INSTITUTE OF SCIENCE & TECHNOLOGY
 (Incorporated as University)
 Thiruvananthapuram, Kerala - 695 022, India
 Thiruvananthapuram - 695 022, India
 Thiruvananthapuram - 695 022, India

Wastewater Management System

Dr. P. Jayasudha
 24.01.18
Dr. P. JAYASUDHA, M.Arch, Ph.D.
 Registered Architect
 Ref. No. CA/98/23822

V.A. Shanmugavelu
 24.01.18
Dr. V.A. SHANMUGAVELU,
 B.E.(Civil & Structures), M.E.(Structures), Ph.D.(Structures),
 M.I.E.(India), Chartered Engineer (India),
 M.I.S.T.E., M.A.C.I., M.I.C.I., M.I.R.C., M.S.E.S.I.,
 10, Vennila Street, Thangam Nagar,
 THANJAVUR - 613 007, Tamil Nadu, India.